


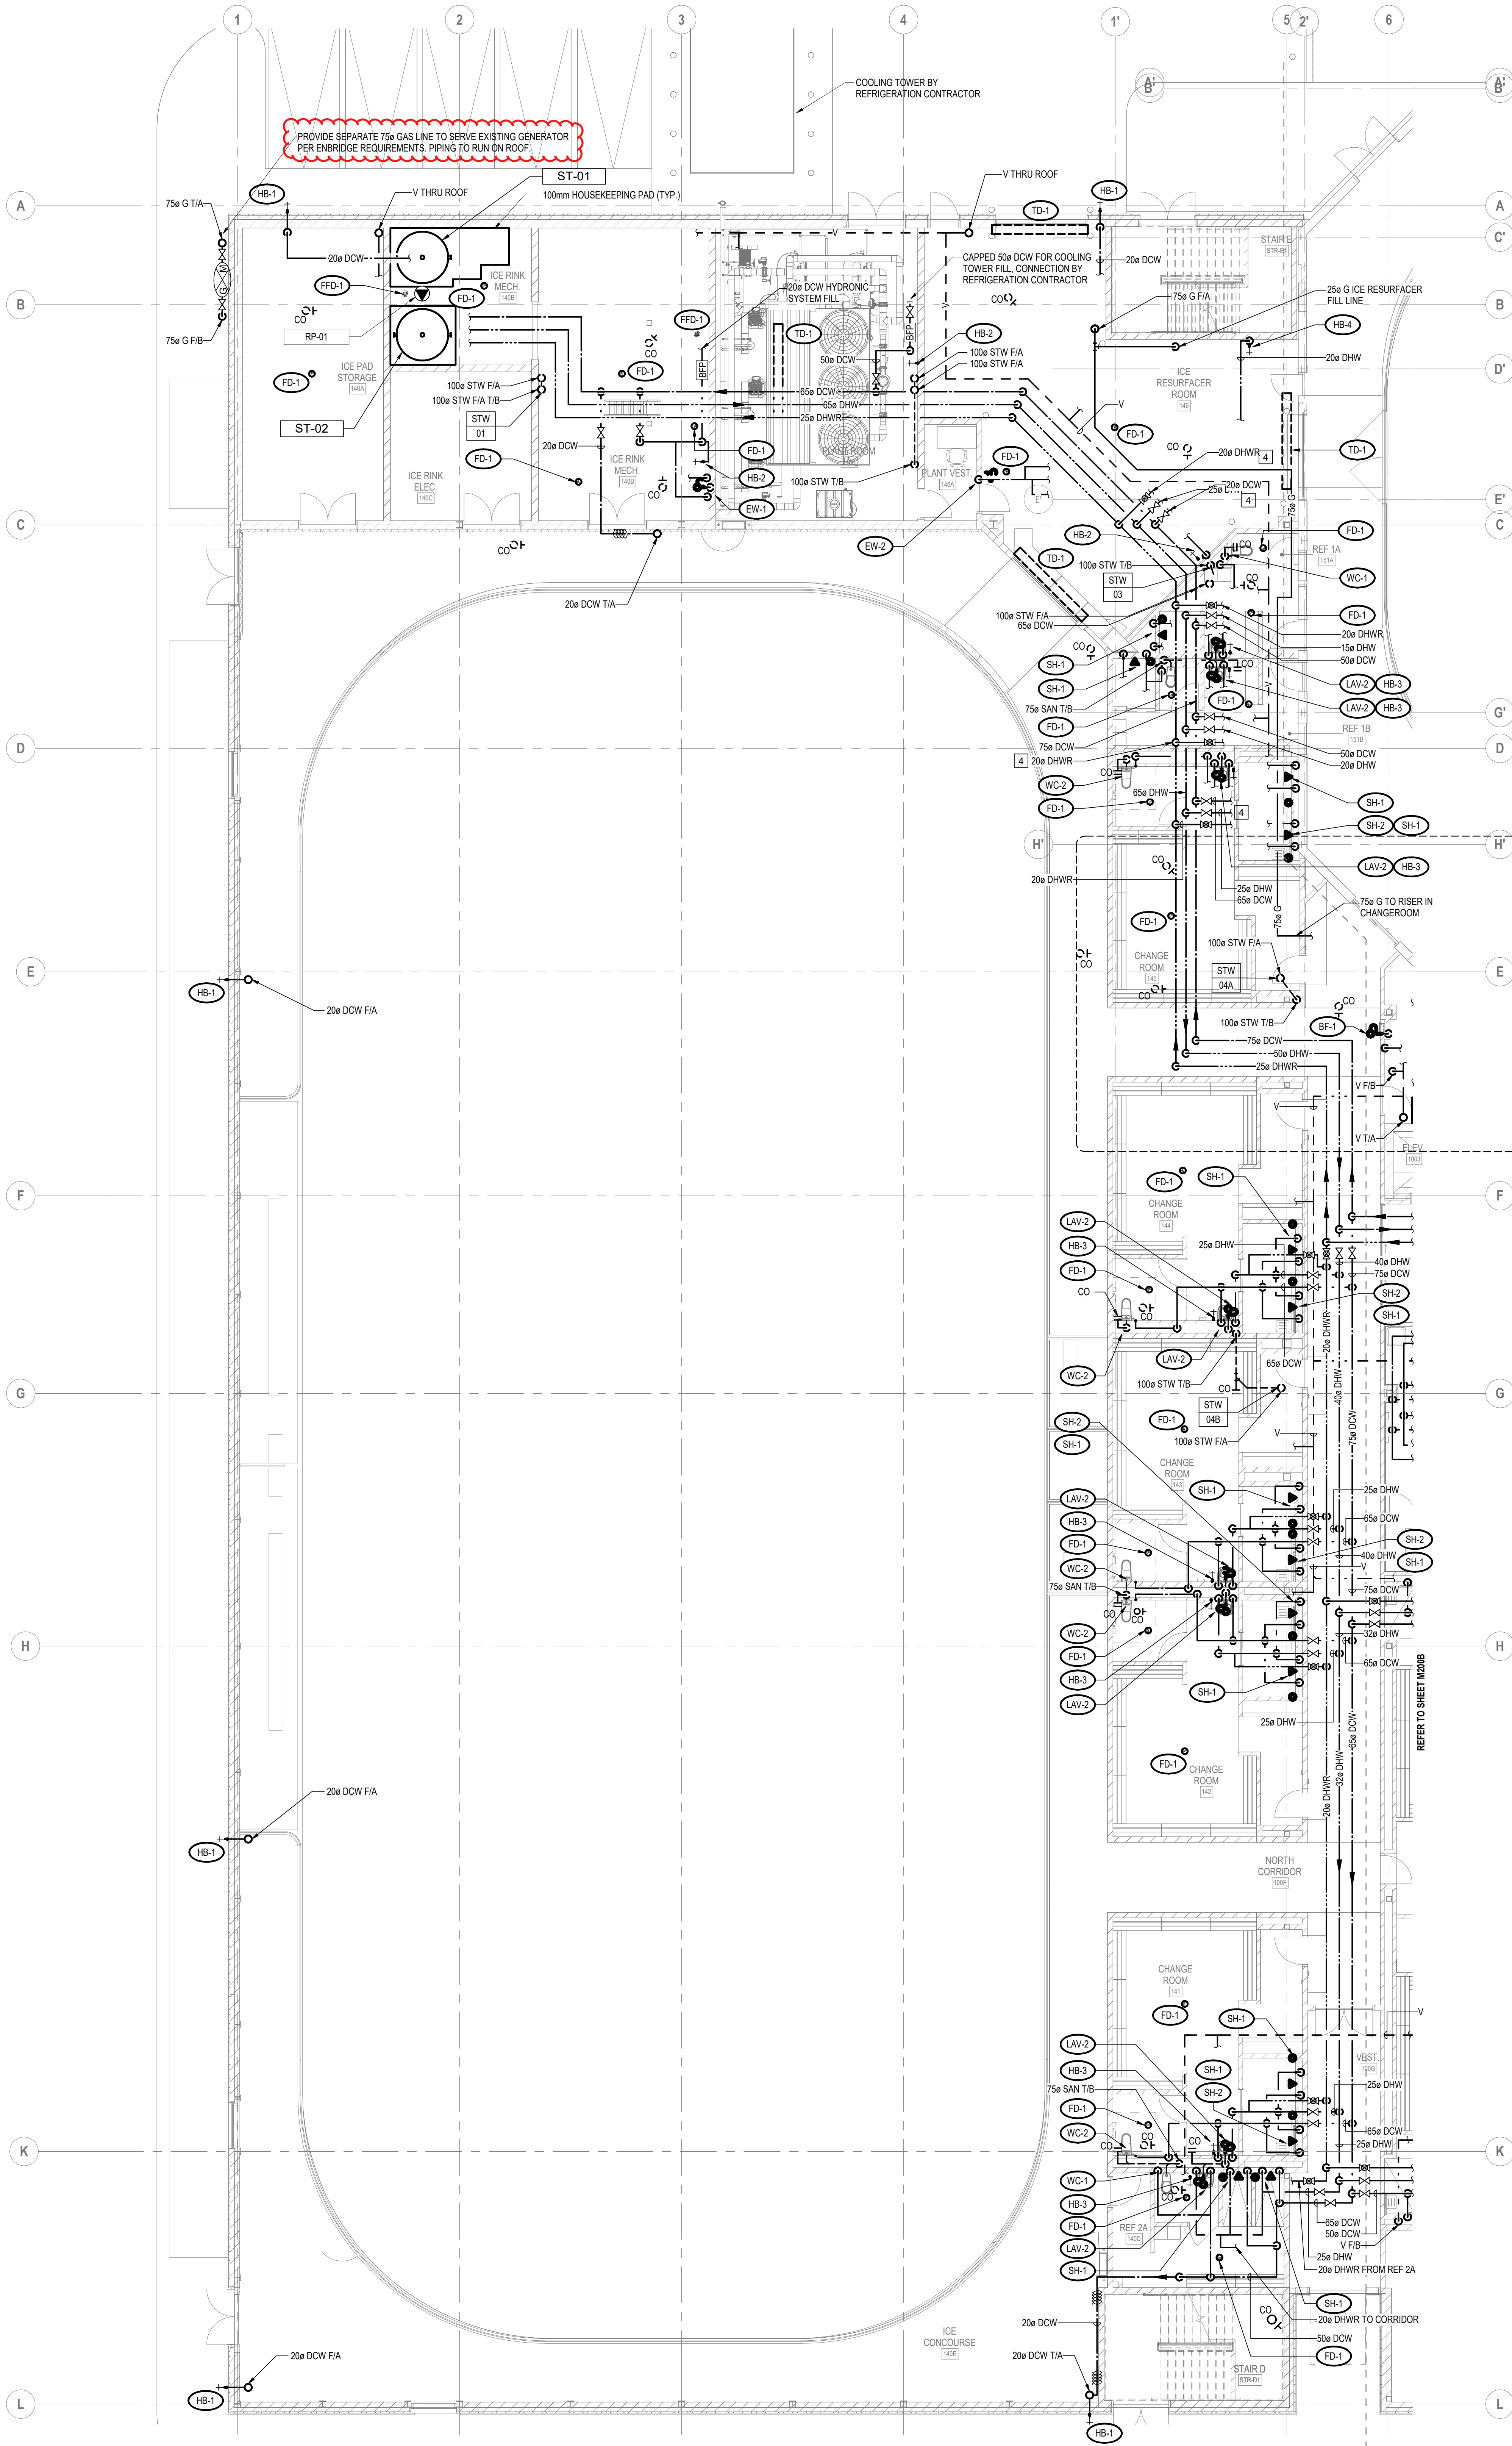

- GENERAL NOTES:**
- A. FINAL LOCATION OF ALL DRAINS TO BE COORDINATED ON SITE WITH FINAL LOCATION OF EQUIPMENT.
- B. PROVIDE PIPING CONNECTION TO ALL PLUMBING FIXTURES AS PER MANUFACTURERS RECOMMENDED INSTALLATION.
- KEYED NOTES:**
- [1] CONNECT NEW FIXTURE TO REPLACED EXISTING PLUMBING SERVICES. CONTRACTOR TO CONFIRM EXISTING PLUMBING SERVICES HAVE CAPACITY TO SERVE NEW FIXTURES.
- [2] REMOVE EXISTING FIXTURE. TEMPORARILY CAP PLUMBING SERVICES. ROUTE NEW PLUMBING SERVICES FROM EXISTING SERVICES TO NEW FIXTURE LOCATION.
- [3] REMOVE EXISTING FIXTURE. TEMPORARILY CAP PLUMBING SERVICES. PLACE NEW FIXTURE IN SAME LOCATION AS EXISTING FIXTURE. MAKE MODIFICATIONS TO EXISTING SERVICES AS REQUIRED TO ACCOMMODATE NEW FIXTURE.
- [4] DHWR, DHW, DCW TO/FROM PLUMBING FIXTURES. SEE SCHEMATICS FOR CONTINUATION.

UNLESS NOTED OTHERWISE, ALL DIMENSIONS ARE TO CENTERLINE UNLESS OTHERWISE NOTED. VERIFY ALL DIMENSIONS, ELEVATIONS, AND DATUM REPORT ANY ERRORS AND/OR DISCREPANCIES TO THE INTEGRAL GROUP PRIOR TO CONSTRUCTION.

DO NOT SCALE DRAWINGS.

THIS DRAWING SUPERSEDES PREVIOUS ISSUES.

UNLESS NOTED OTHERWISE, ALL DIMENSIONS REMAIN THE PROPERTY OF THE INTEGRAL GROUP. THIS DESIGN AND DRAWING MAY NOT BE REPRODUCED WITHOUT PERMISSION OF THE INTEGRAL GROUP.

diamondschmitt

ISSUED

No.	Date	Description
1	2020-12-14	ISSUED FOR 60% CD
2	2021-03-26	ISSUED FOR 100% CD
3	2021-06-17	ISSUED FOR 90% CD REVIEW
4	2021-09-24	ISSUED FOR 90% CD
5	2021-11-01	ISSUED FOR REVIEW
6	2021-11-10	ISSUED FOR 100% CD
7	2022-02-18	ISSUED FOR TENDER
8	2022-06-03	ISSUED FOR BUILDING PERMIT
9	2023-03-31	ISSUED FOR TENDER
10	2023-09-08	ISSUED FOR CONSTRUCTION

INTEGRAL

Toronto Design Studio
380 Wellington Street West,
Toronto, ON Canada M5V 1E3

t: +1 416.488.4425
e: info@integralgroup.com
www.integralgroup.com

Project North

True North

Chris Gibson Recreation Centre
Renovation and Addition


125 McLaughlin Road North
Brampton, ON
L6Y 1Y7

LEVEL 01 - NORTH PLUMBING AND
DRAINAGE PLAN

Scale: 1" = 100'
Project No: 210305
Date: 2022-04-06

BM 180 1010114-CDRC-2021-0082-MECH-620-11

2023-09-07 13:28:51 PM

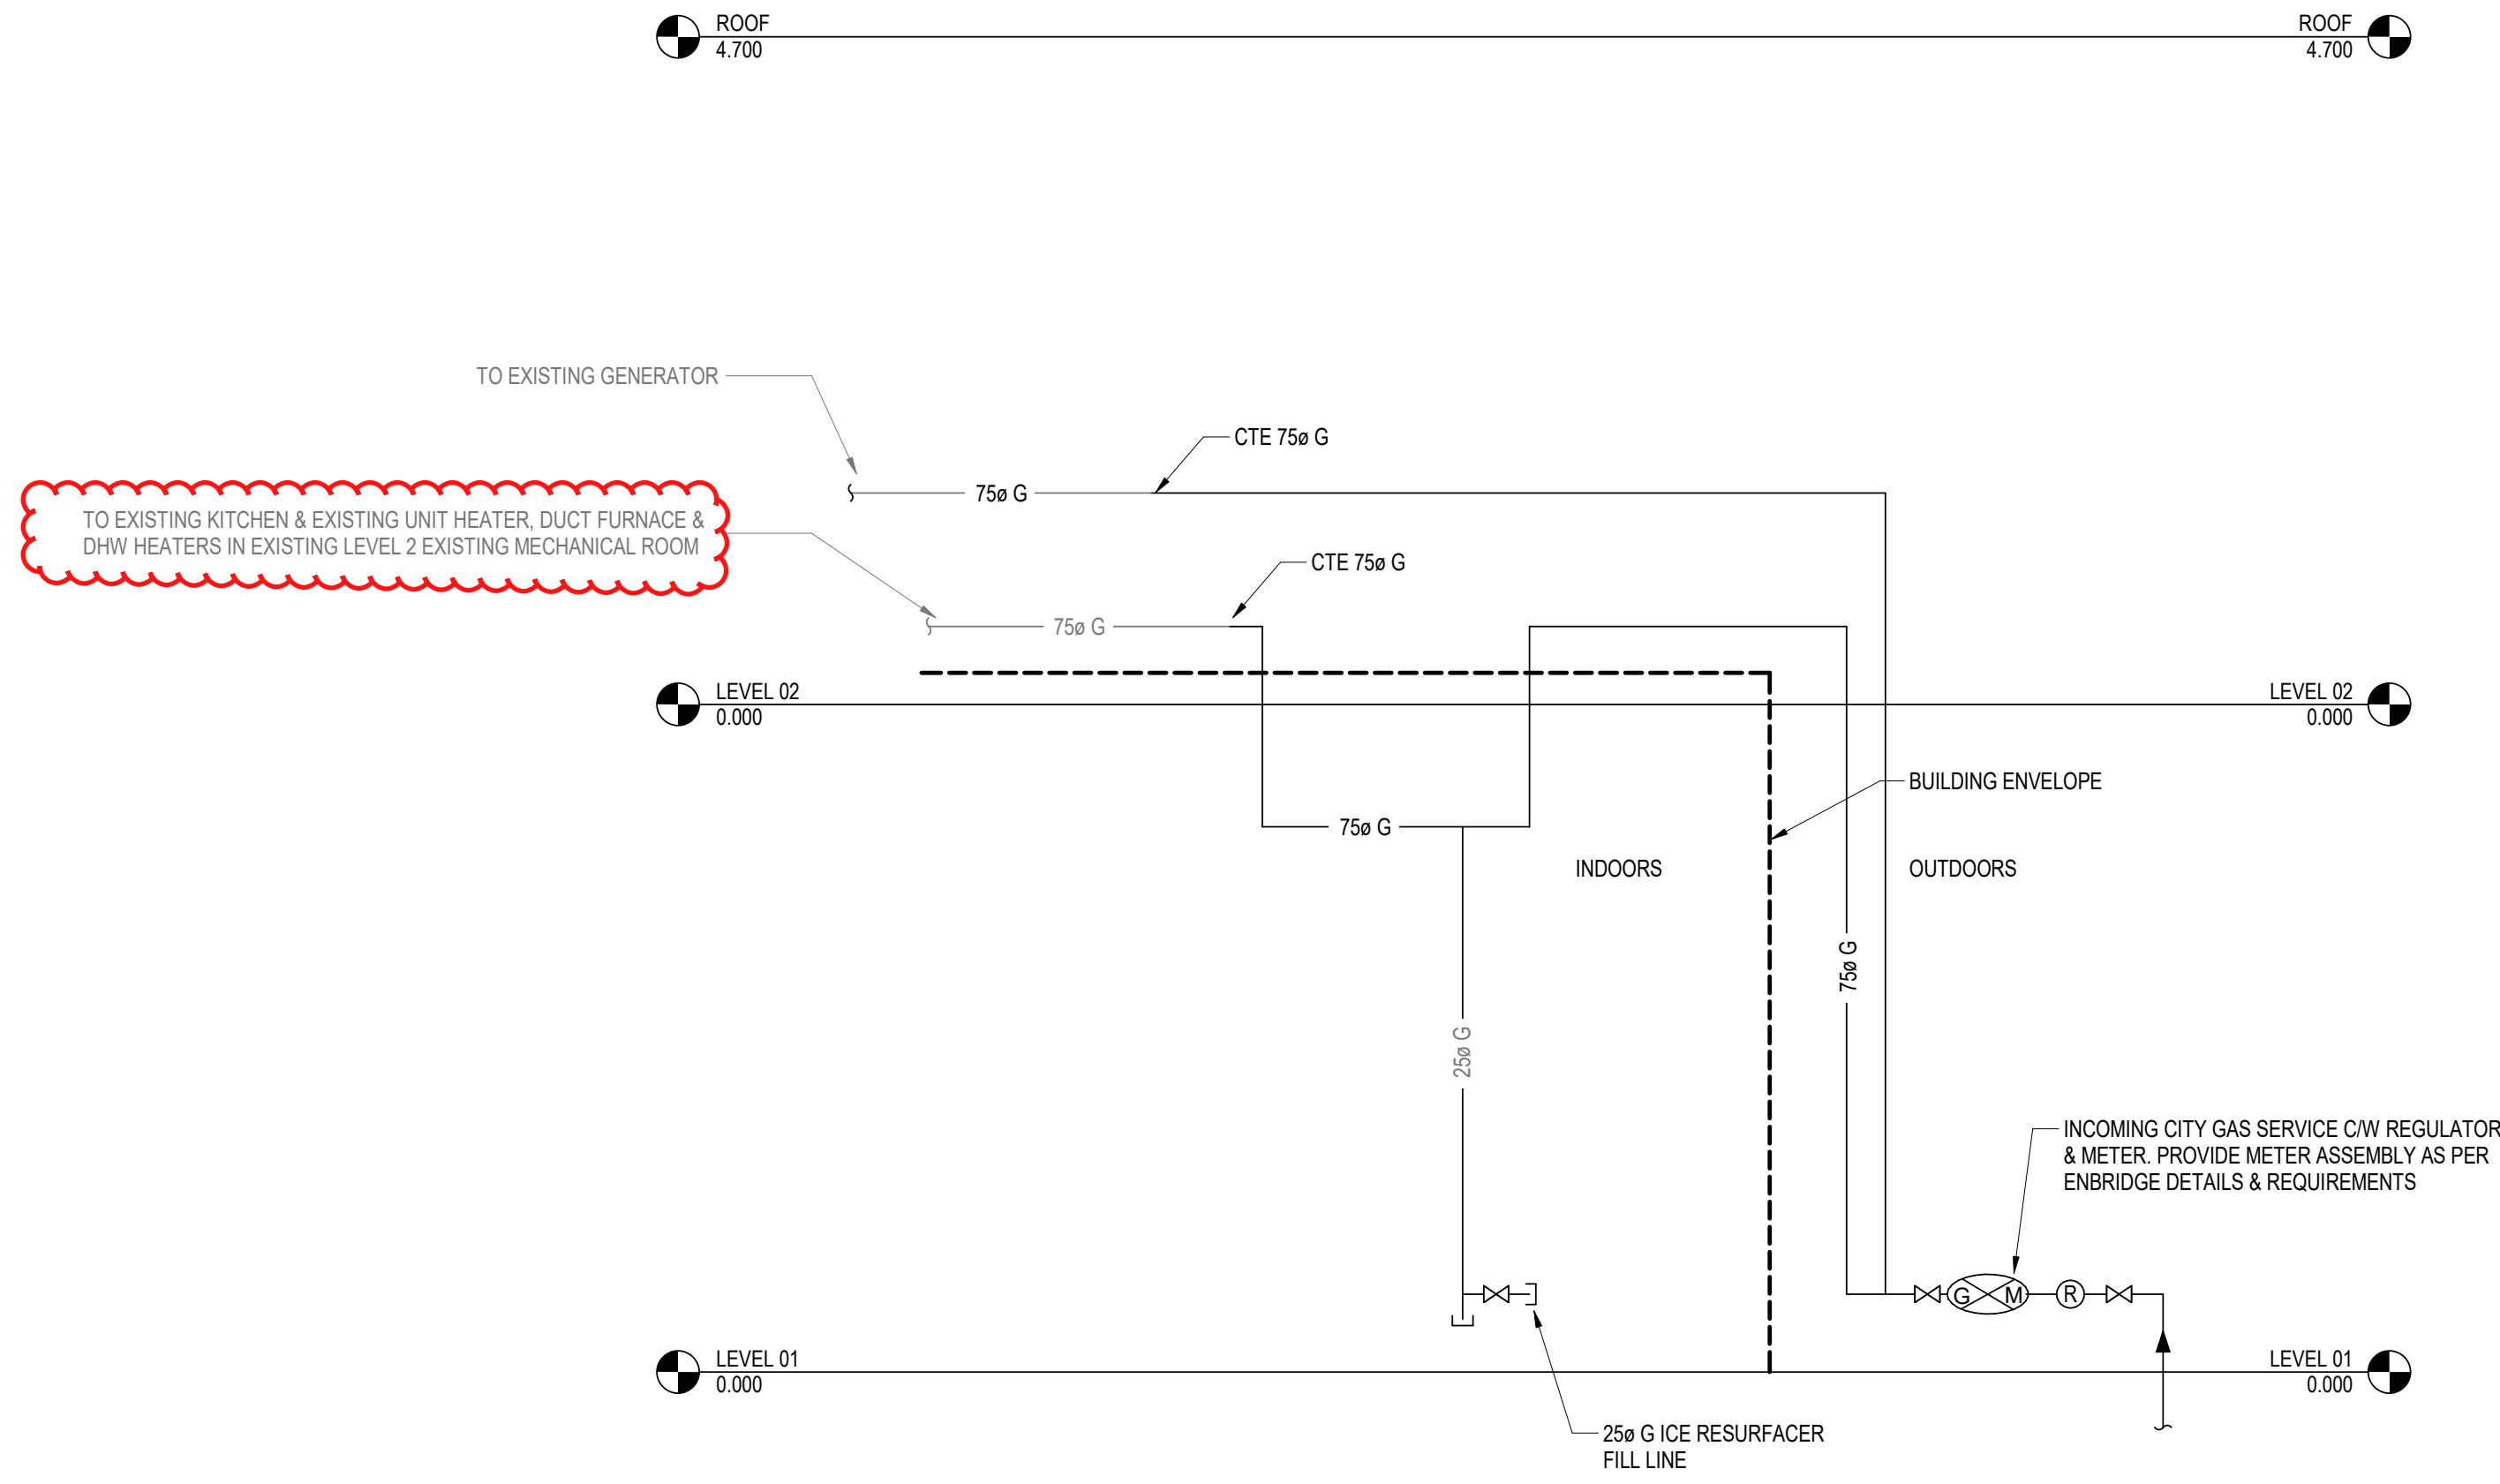

UNLESS NOTED OTHERWISE, ALL DIMENSIONS ARE TO CENTERLINE UNLESS OTHERWISE NOTED. VERIFY ALL DIMENSIONS, ELEVATIONS, AND DATUMS. REPORT ANY ERRORS AND/OR DISCREPANCIES TO THE INTEGRAL GROUP PRIOR TO CONSTRUCTION.

DO NOT SCALE DRAWINGS.

THIS DRAWING SUPERSEDES PREVIOUS ISSUES.

UNLESS NOTED OTHERWISE, ALL DIMENSIONS REMAIN THE PROPERTY OF THE INTEGRAL GROUP. THIS DESIGN AND DRAWING MAY NOT BE REPRODUCED WITHOUT PERMISSION OF THE INTEGRAL GROUP.

diamondschmitt

ISSUED

No.	Date	Description
1	2021-06-17	ISSUED FOR 50% CD REVIEW
2	2021-09-24	ISSUED FOR 90% CD
3	2021-11-01	ISSUED FOR REVIEW
4	2021-11-10	ISSUED FOR 100% CD
5	2022-02-18	ISSUED FOR TENDER
6	2022-06-03	ISSUED FOR BUILDING PERMIT
7	2023-03-31	ISSUED FOR TENDER
8	2023-09-08	ISSUED FOR CONSTRUCTION



INTEGRAL

Toronto Design Studio
390 Wellington Street West,
Toronto, ON Canada M5V 1E3

t: +1 416 488 4425
e: info@integralgroup.com
www.integralgroup.com
Registered Professional Engineers & Architects

Project North

True North

Chris Gibson Recreation Centre
Renovation and Addition

125 McLaughlin Road North
Brampton, ON
L6R 1Y7

GAS SCHEMATICS

Scale: 1" = 1'
Project No: 210305
Date: 2022-04-06